




ELECTRICAL INDEX LABEL GUIDE - NECA 100	
Luminaire	
LUMINAIRE STRIP TYPE	I-I
FLUORESCENT STRIP LUMINAIRE	I-I
FIXTURE—HEAD SPOTLIGHT	O-O
SURFACE MOUNTED FIXTURE	O-O
RECESSED FIXTURE	O-O
WALL MOUNTED FIXTURE	O-O
SUSPENDED PENDANT	O-O
IN-GROUND OR FLOOR MOUNTED	O-O
BOLLARD TYPE SITE LUMINAIRE	O-O
LUMINAIRE PROVIDING EMERGENCY ILLUMINATION	O-O
TRACK LIGHT FIXTURE	O-O
Outlets	
FLOOR DUPLEX OUTLET	O-O
FLOOR SINGLE OUTLET	O-O
DUPLEX OUTLET	O-O
SINGLE OUTLET	O-O
DOUBLE DUPLEX OUTLET	O-O
JUNCTION BOX OUTLET	O-O
DUPLEX OUTLET - CEILING MOUNTED	O-O
DOUBLE DUPLEX OUTLET - CEILING MOUNTED	O-O
SINGLE OUTLET - CEILING MOUNTED	O-O
SINGLE POLE SWITCH	O-O
DOUBLE POLE SWITCH	O-O
DIMMER SWITCH	O-O
Security	
CCVT SECURITY CAMERA	O-O
DOORBELL	O-O
ELECTRIC DOOR OPENER	O-O
INTERCOM UNIT	O-O
MOTION DETECTOR	O-O
SECURITY CARD READER	O-O
SECURITY CONTROL PANEL	O-O
SECURITY EXIT PUSH BUTTON	O-O
HVAC	
THERMOSTAT	O-O
CEILING FAN	O-O
WALL FAN	O-O
WATER HEATER	O-O
Power	
DISTRIBUTION PANEL	O-O
Fire Alarm	
FIRE ALARM CONTROL PANEL	O-O
KITCHEN HOOD SYSTEM	O-O
FIRE ALARM SYSTEM	O-O
EXHAUST FAN	O-O
AUTOMATIC HEAT DETECTOR	O-O
Communication	
TELEPHONE/DATA OUTLET	O-O
CABLE ANTENNA SYSTEM OUTLET	O-O
MICROPHONE OUTLET- WALL MOUNTED	O-O
SPEAKER - CEILING MOUNTED	O-O
Others	
UNIDENTIFIED ELEMENT	O-O

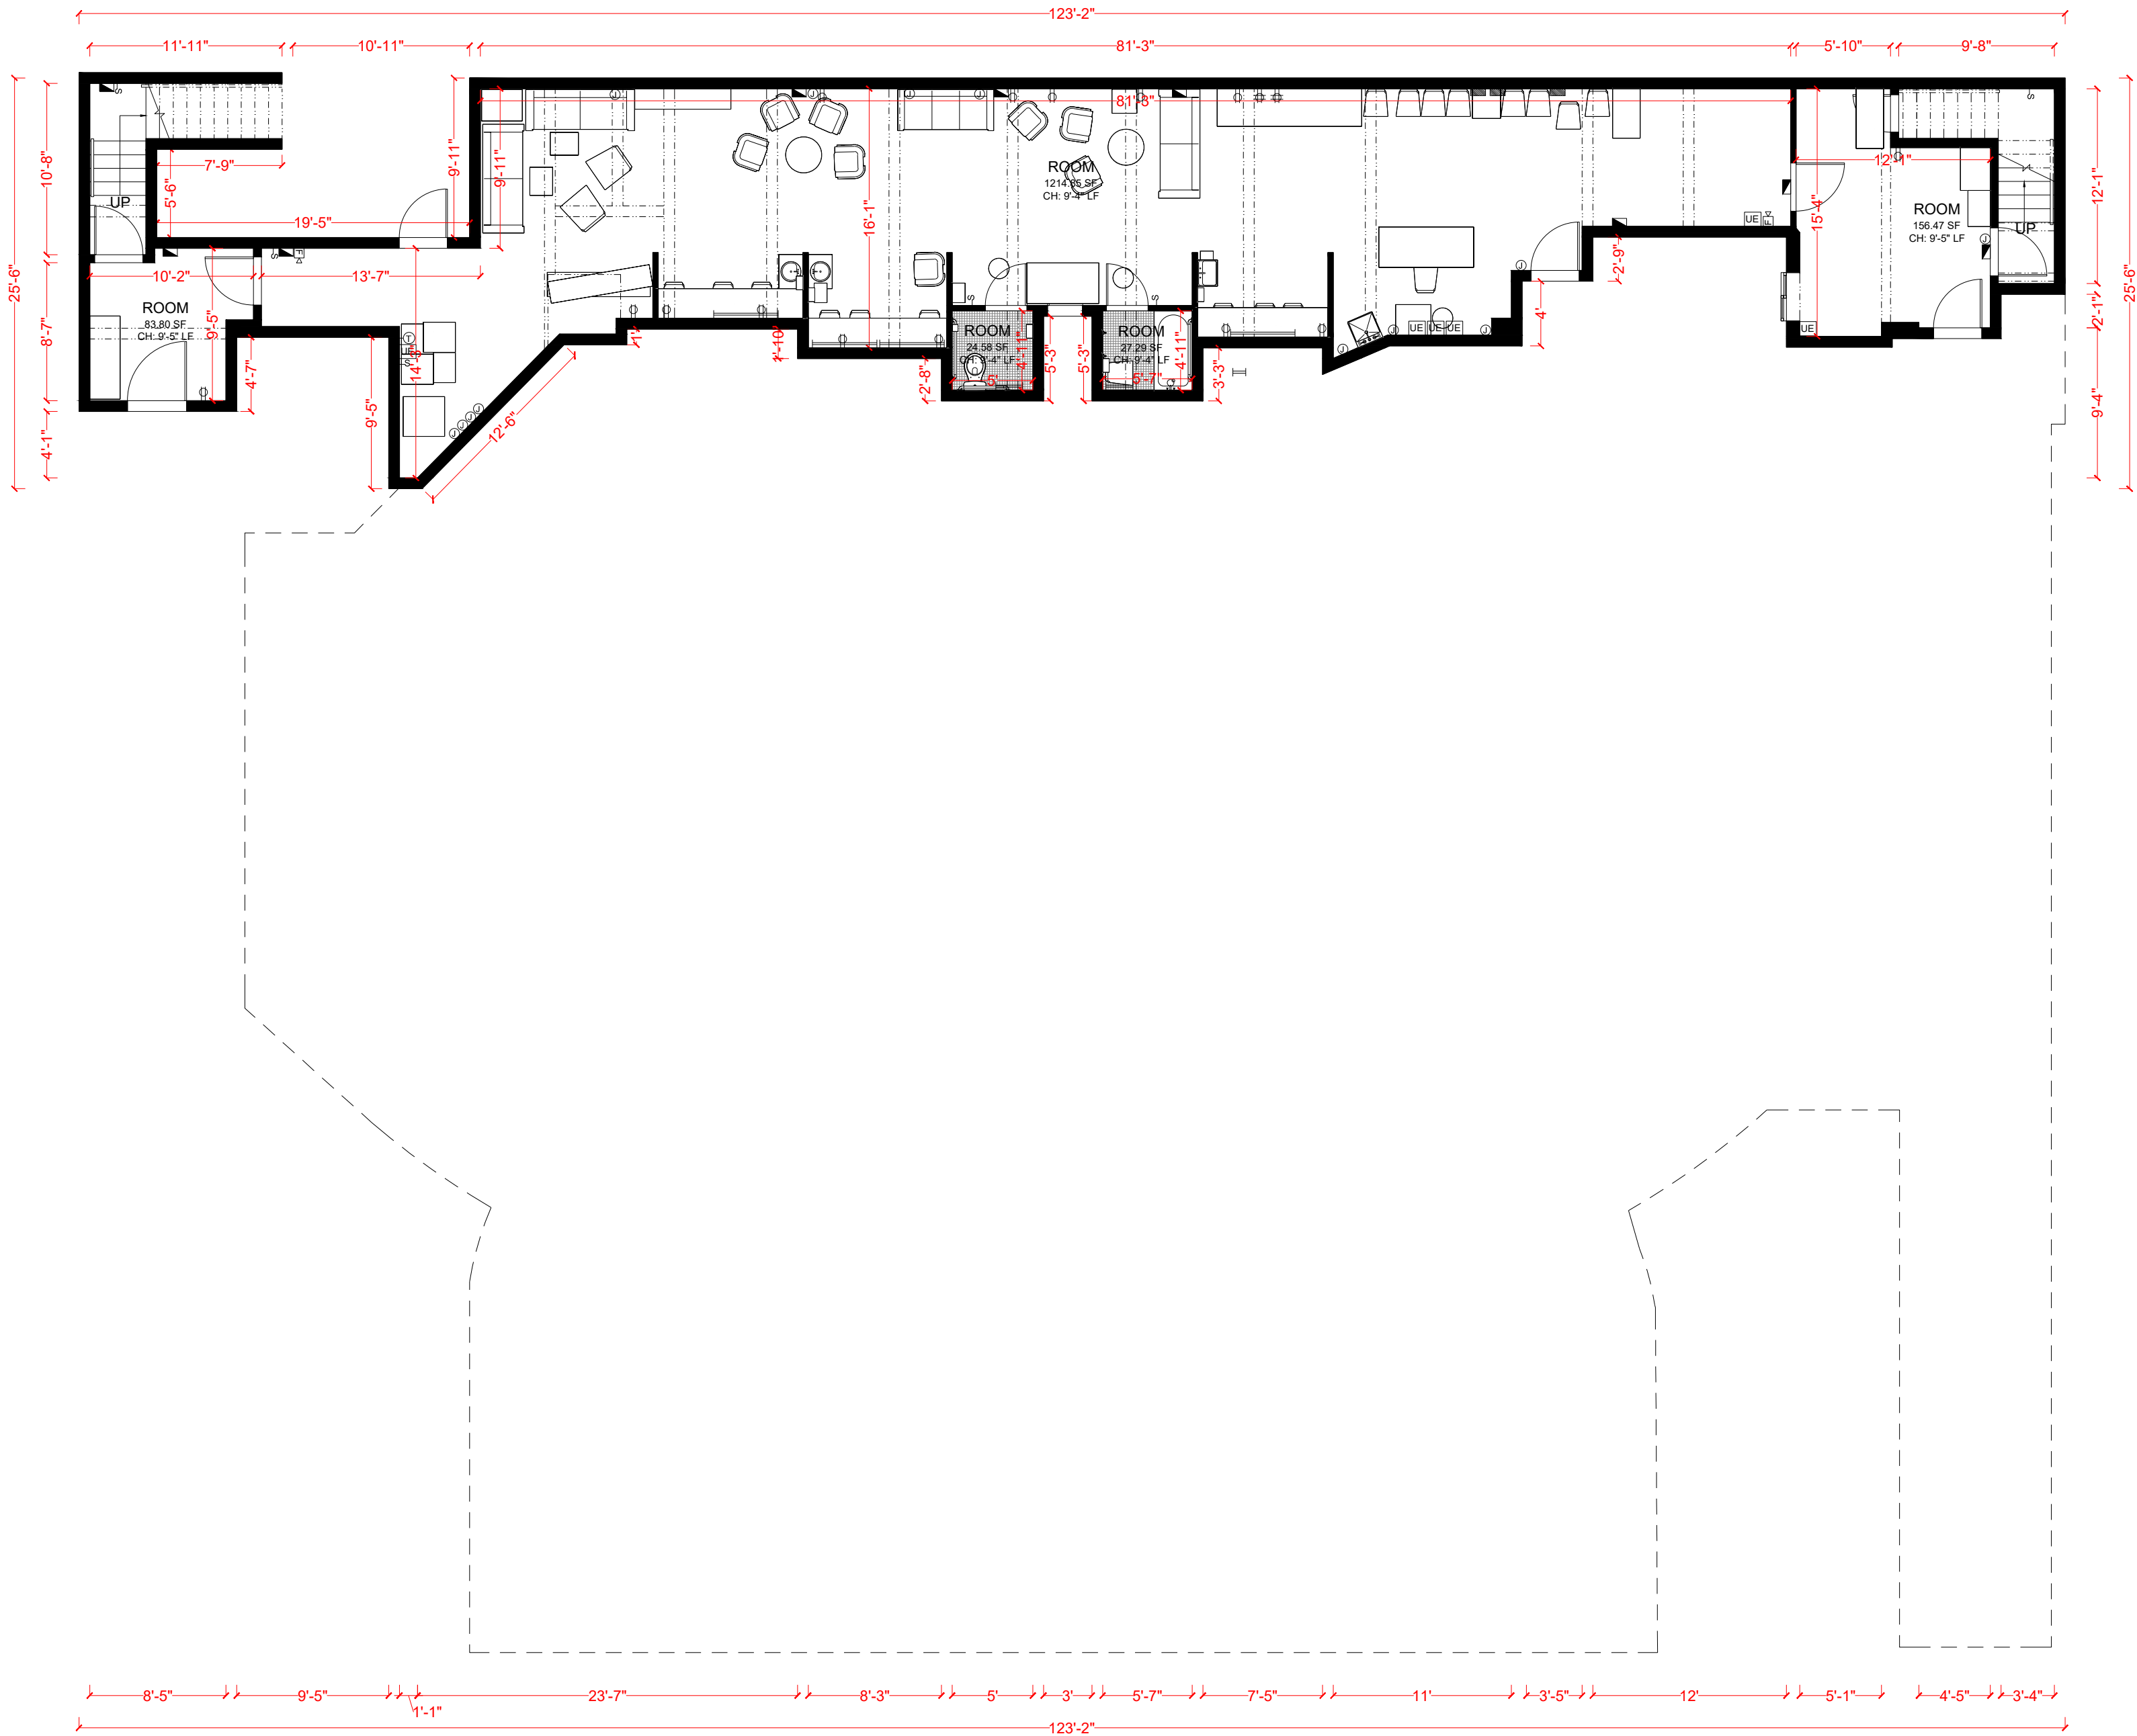

123 W 43RD ST, NEW YORK

BASEMENT

FLOOR AREA:	1661.87 SF
BUILDING ELEMENTS:	ARCH + FURN + ELEC
DATE ISSUE:	10-08-2026
PROJECT SCALE:	1/8"=1'
PAPER SIZE:	A2
GRAPHIC SCALE:	0 5' 10' 15'