




ELECTRICAL INDEX LABEL GUIDE - NECA 100		
Luminaire		
LUMINAIRE STRIP TYPE		I-I
FLUORESCENT STRIP LUMINAIRE		I-I
FIXTURE—HEAD SPOTLIGHT		O-O
SURFACE MOUNTED FIXTURE		O-O
RECESSED FIXTURE		O-O
WALL MOUNTED FIXTURE		O-O
SUSPENDED PENDANT		O-O
IN-GROUND OR FLOOR MOUNTED		O-O
BOLLARD TYPE SITE LUMINAIRE		O-O
LUMINAIRE PROVIDING EMERGENCY ILLUMINATION		O-O
TRACK LIGHT FIXTURE		O-O
Outlets		
FLOOR DUPLEX OUTLET		O-O
FLOOR SINGLE OUTLET		O-O
DUPLEX OUTLET		O-O
SINGLE OUTLET		O-O
DOUBLE DUPLEX OUTLET		O-O
JUNCTION BOX OUTLET		O-O
DUPLEX OUTLET - CEILING MOUNTED		O-O
DOUBLE DUPLEX OUTLET - CEILING MOUNTED		O-O
SINGLE OUTLET - CEILING MOUNTED		O-O
SINGLE POLE SWITCH		I-S
DOUBLE POLE SWITCH		I-S
DIMMER SWITCH		I-D
Security		
CCVT SECURITY CAMERA		C-C
DOORBELL		B-B
ELECTRIC DOOR OPENER		DR
INTERCOM UNIT		IC
MOTION DETECTOR		MD
SECURITY CARD READER		CR
SECURITY CONTROL PANEL		SCP
SECURITY EXIT PUSH BUTTON		EB
HVAC		
THERMOSTAT		H-T
CEILING FAN		C-F
WALL FAN		W-F
WATER HEATER		W-H
Power		
DISTRIBUTION PANEL		DP
Fire Alarm		
FIRE ALARM CONTROL PANEL		FACP
KITCHEN HOOD SYSTEM		KHS
FIRE ALARM SYSTEM		FAS
EXHAUST FAN		EF
AUTOMATIC HEAT DETECTOR		AD
Communication		
TELEPHONE/DATA OUTLET		TO
CABLE ANTENNA SYSTEM OUTLET		CASO
MICROPHONE OUTLET- WALL MOUNTED		MO
SPEAKER - CEILING MOUNTED		SC
Others		
UNIDENTIFIED ELEMENT		UE

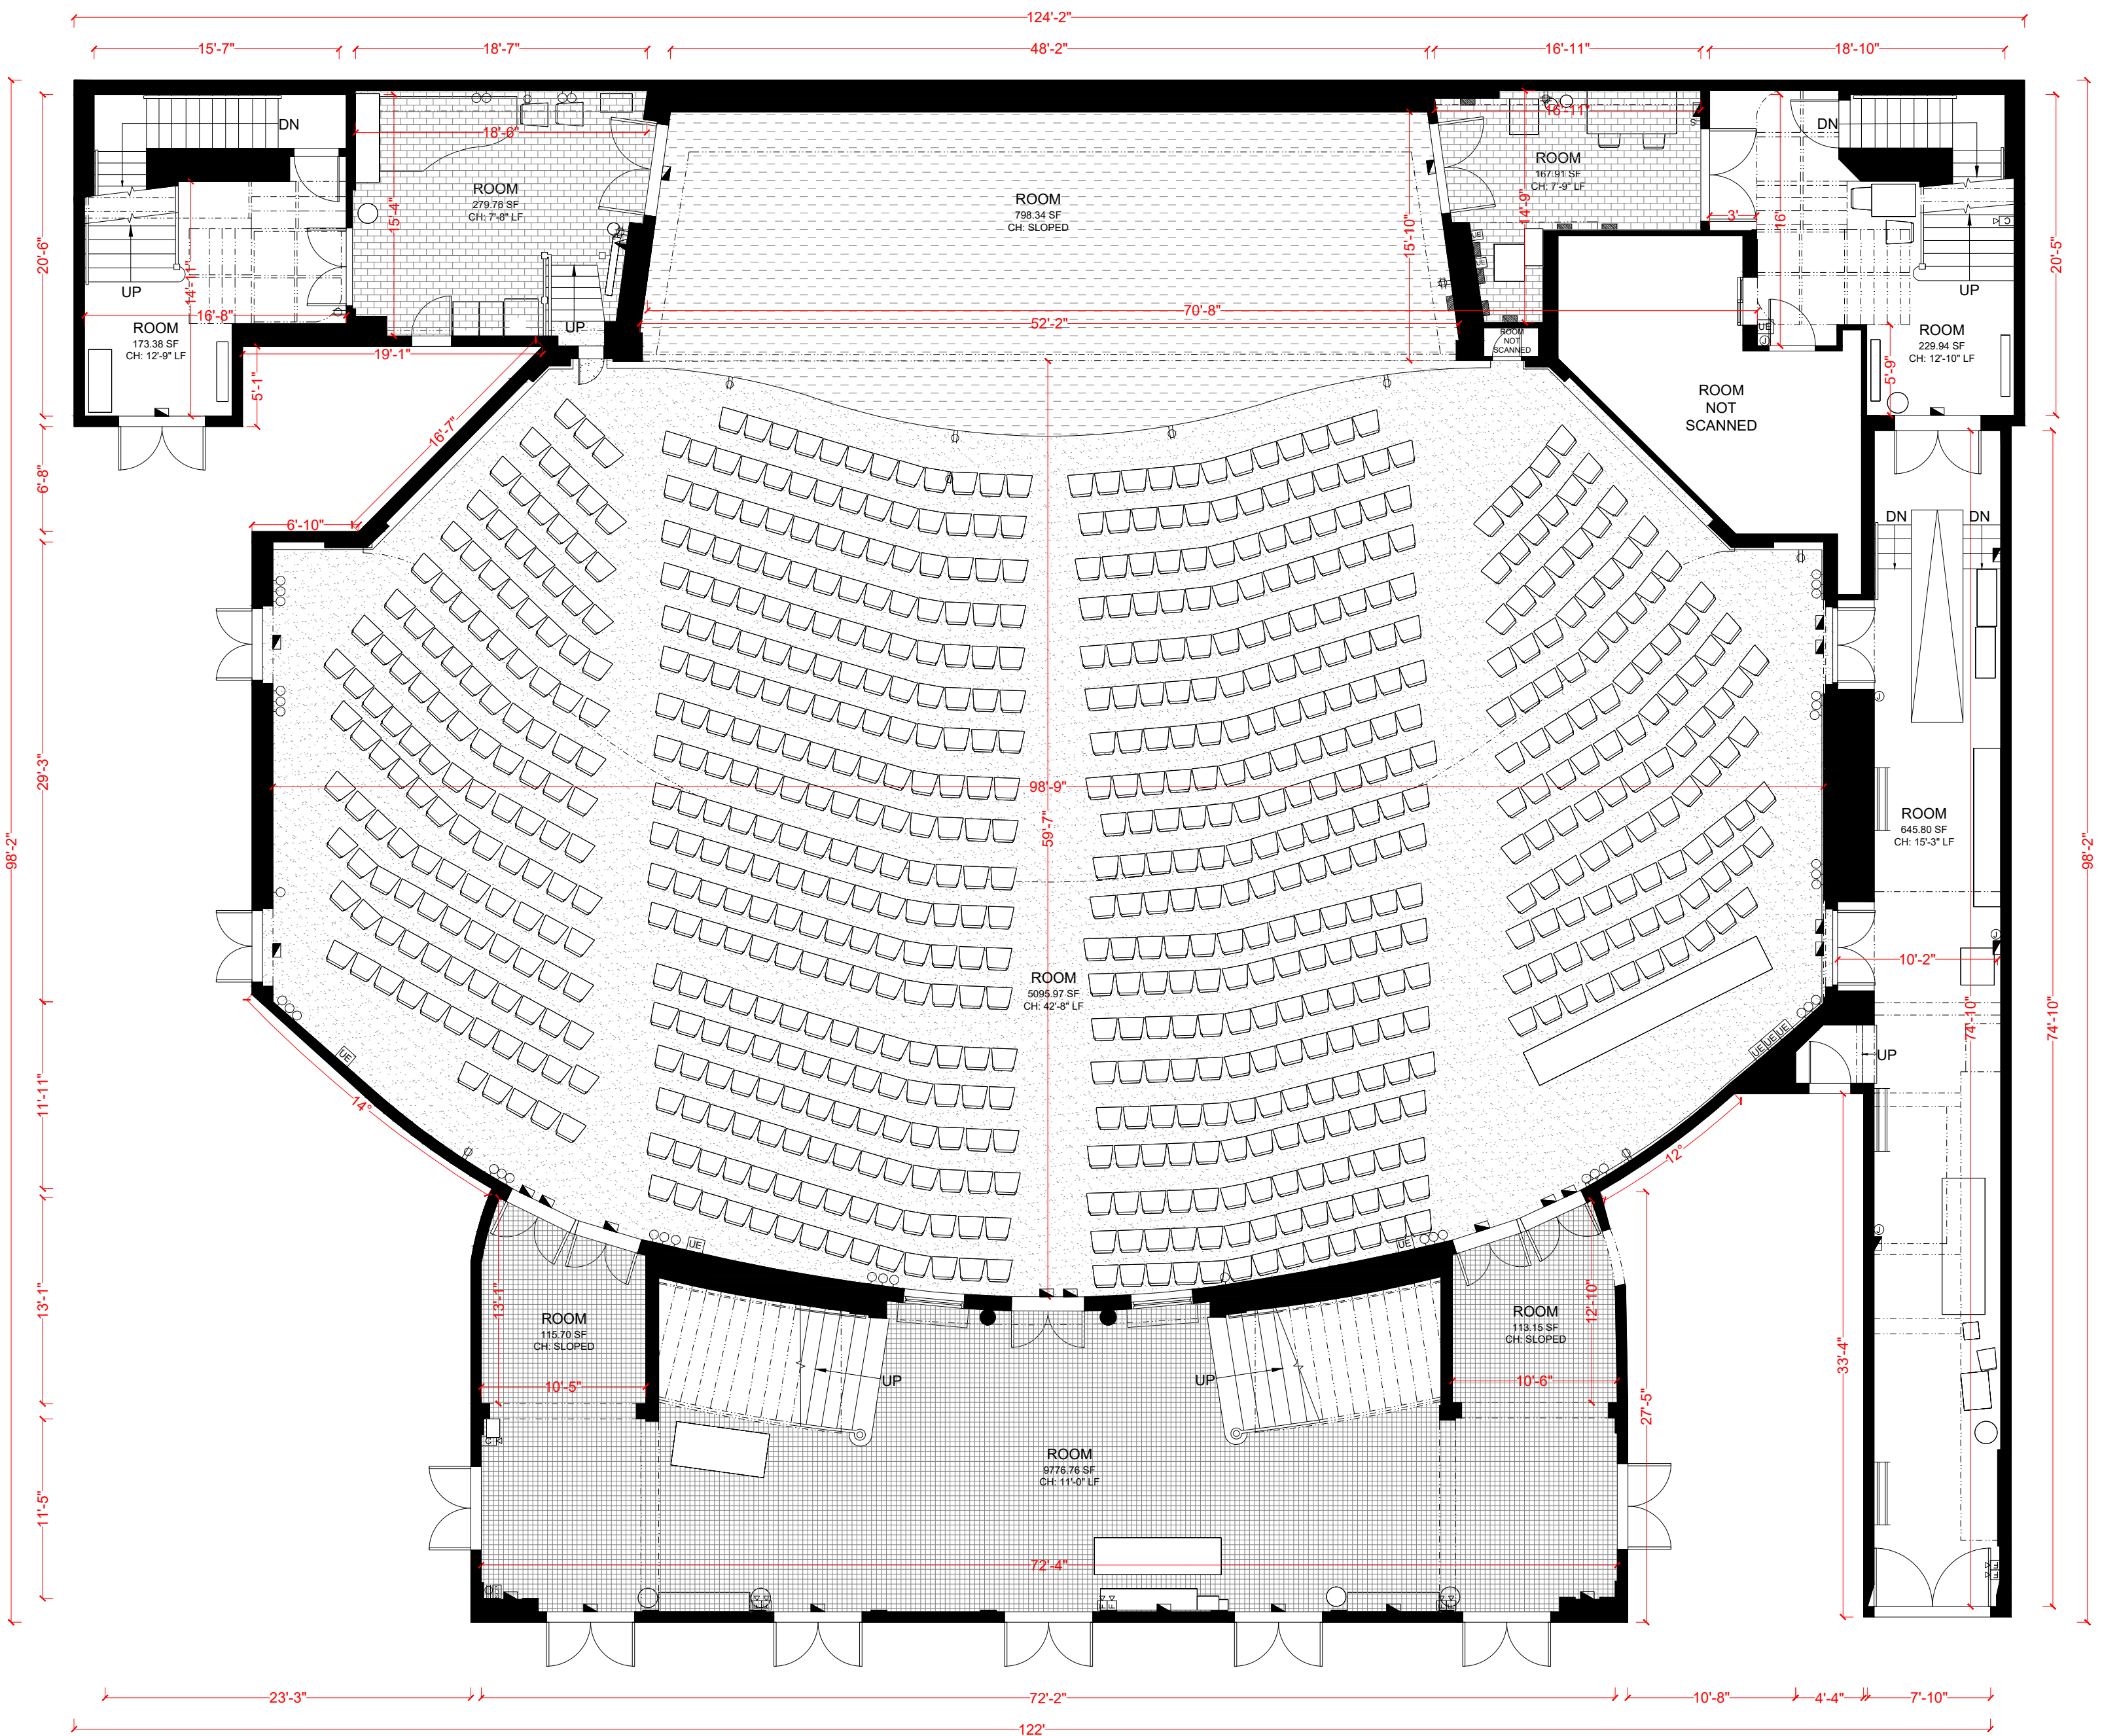

123 W 43RD ST, NEW YORK

GROUND FLOOR

FLOOR AREA:	9776.76 SF
BUILDING ELEMENTS:	ARCH + FURN + ELEC
DATE ISSUE:	10-08-2026
PROJECT SCALE:	1/8"=1'
PAPER SIZE:	A2
GRAPHIC SCALE:	0 5' 10' 15'