




ELECTRICAL INDEX LABEL GUIDE - NECA 100		
Luminaire		
LUMINAIRE STRIP TYPE		⎓
FLUORESCENT STRIP LUMINAIRE		⎓
FIXTURE—HEAD SPOTLIGHT		⊙
SURFACE MOUNTED FIXTURE		⊙
RECESSED FIXTURE		⊙
WALL MOUNTED FIXTURE		⊙
SUSPENDED PENDANT		⊙
IN-GROUND OR FLOOR MOUNTED		⊙
BOLLARD TYPE SITE LUMINAIRE		⊙
LUMINAIRE PROVIDING EMERGENCY ILLUMINATION		⊙
TRACK LIGHT FIXTURE		⎓
Outlets		
FLOOR DUPLEX OUTLET		⊕
FLOOR SINGLE OUTLET		⊕
DUPLEX OUTLET		⊕
SINGLE OUTLET		⊕
DOUBLE DUPLEX OUTLET		⊕
JUNCTION BOX OUTLET		⊕
DUPLEX OUTLET - CEILING MOUNTED		⊕
DOUBLE DUPLEX OUTLET - CEILING MOUNTED		⊕
SINGLE OUTLET - CEILING MOUNTED		⊕
SINGLE POLE SWITCH		⊕
DOUBLE POLE SWITCH		⊕
DIMMER SWITCH		⊕
Security		
CCVT SECURITY CAMERA		⊕
DOORBELL		⊕
ELECTRIC DOOR OPENER		⊕
INTERCOM UNIT		⊕
MOTION DETECTOR		⊕
SECURITY CARD READER		⊕
SECURITY CONTROL PANEL		⊕
SECURITY EXIT PUSH BUTTON		⊕
HVAC		
THERMOSTAT		⊕
CEILING FAN		⊕
WALL FAN		⊕
WATER HEATER		⊕
Power		
DISTRIBUTION PANEL		⊕
Fire Alarm		
FIRE ALARM CONTROL PANEL		⊕
KITCHEN HOOD SYSTEM		⊕
FIRE ALARM SYSTEM		⊕
EXHAUST FAN		⊕
AUTOMATIC HEAT DETECTOR		⊕
Communication		
TELEPHONE/DATA OUTLET		⊕
CABLE ANTENNA SYSTEM OUTLET		⊕
MICROPHONE OUTLET- WALL MOUNTED		⊕
SPEAKER - CEILING MOUNTED		⊕
Others		
UNIDENTIFIED ELEMENT		⊕

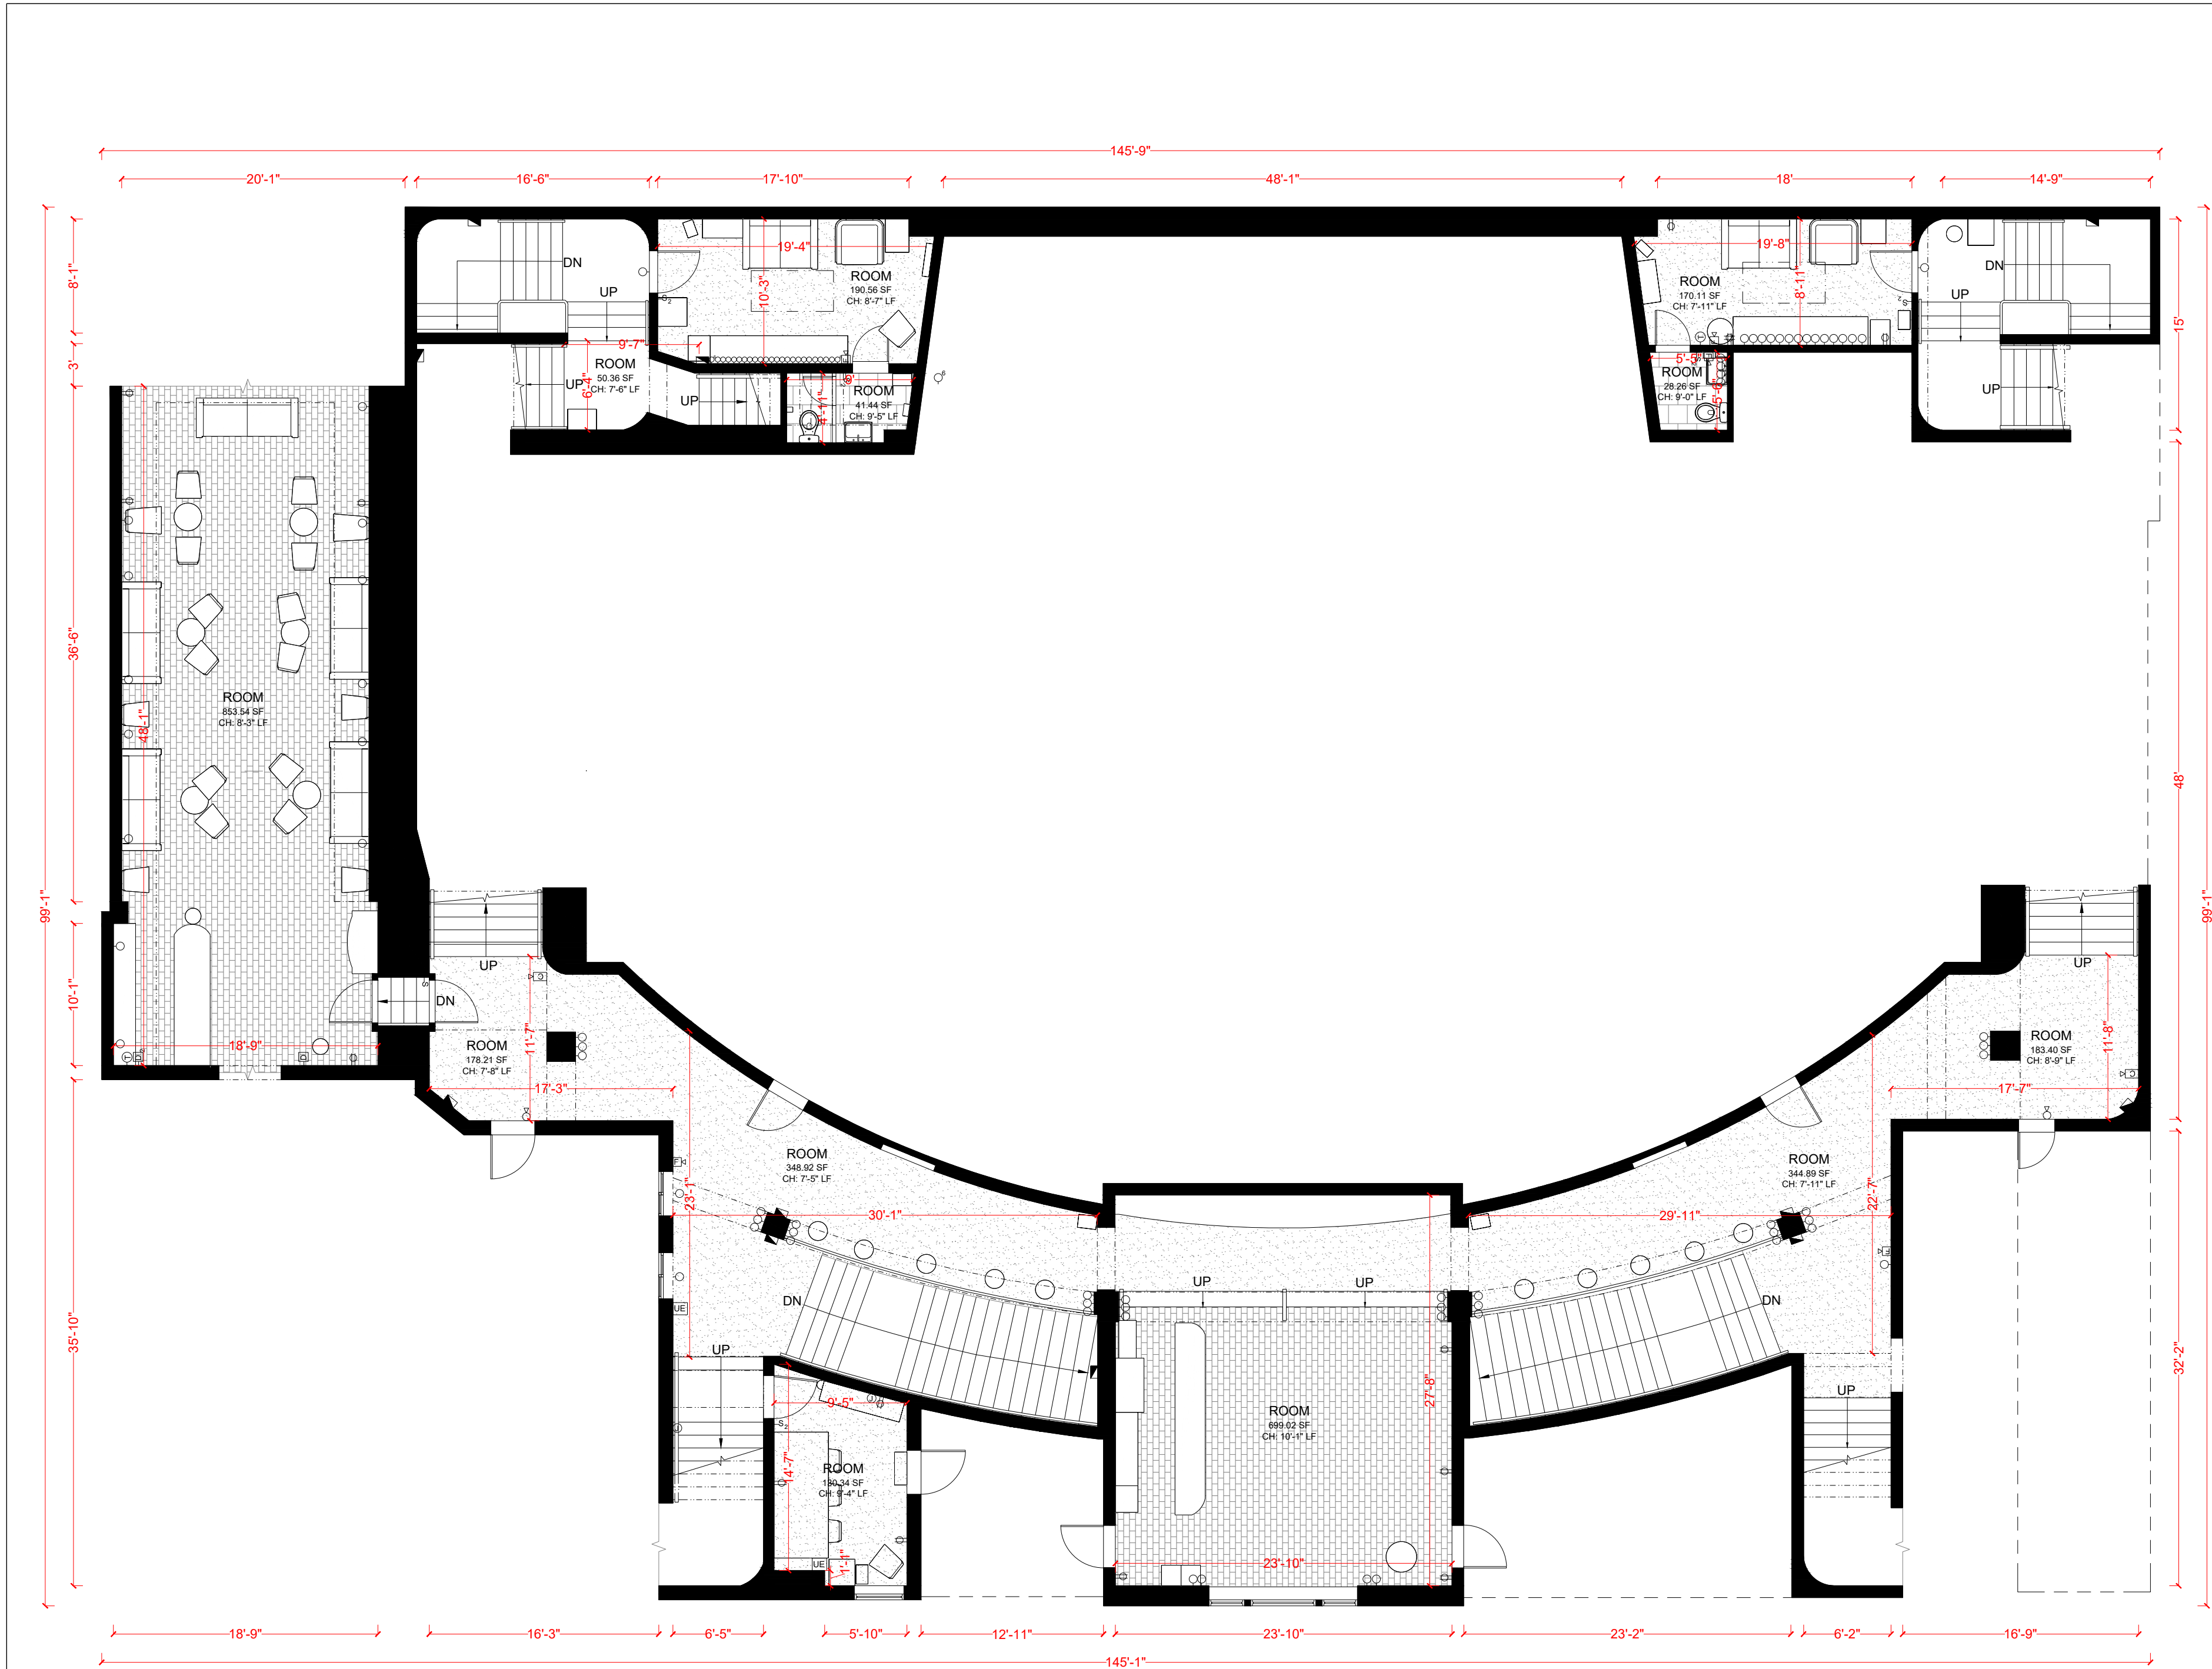

123 W 43RD ST, NEW YORK

SECOND FLOOR

FLOOR AREA: 4,335.89 SF

BUILDING ELEMENTS: ARCH + FURN + ELEC

DATE ISSUE: 10-08-2026

PROJECT SCALE: 1/8"=1'

PAPER SIZE: A2

GRAPHIC SCALE:
0 5' 10' 15'